


SECTION A-A

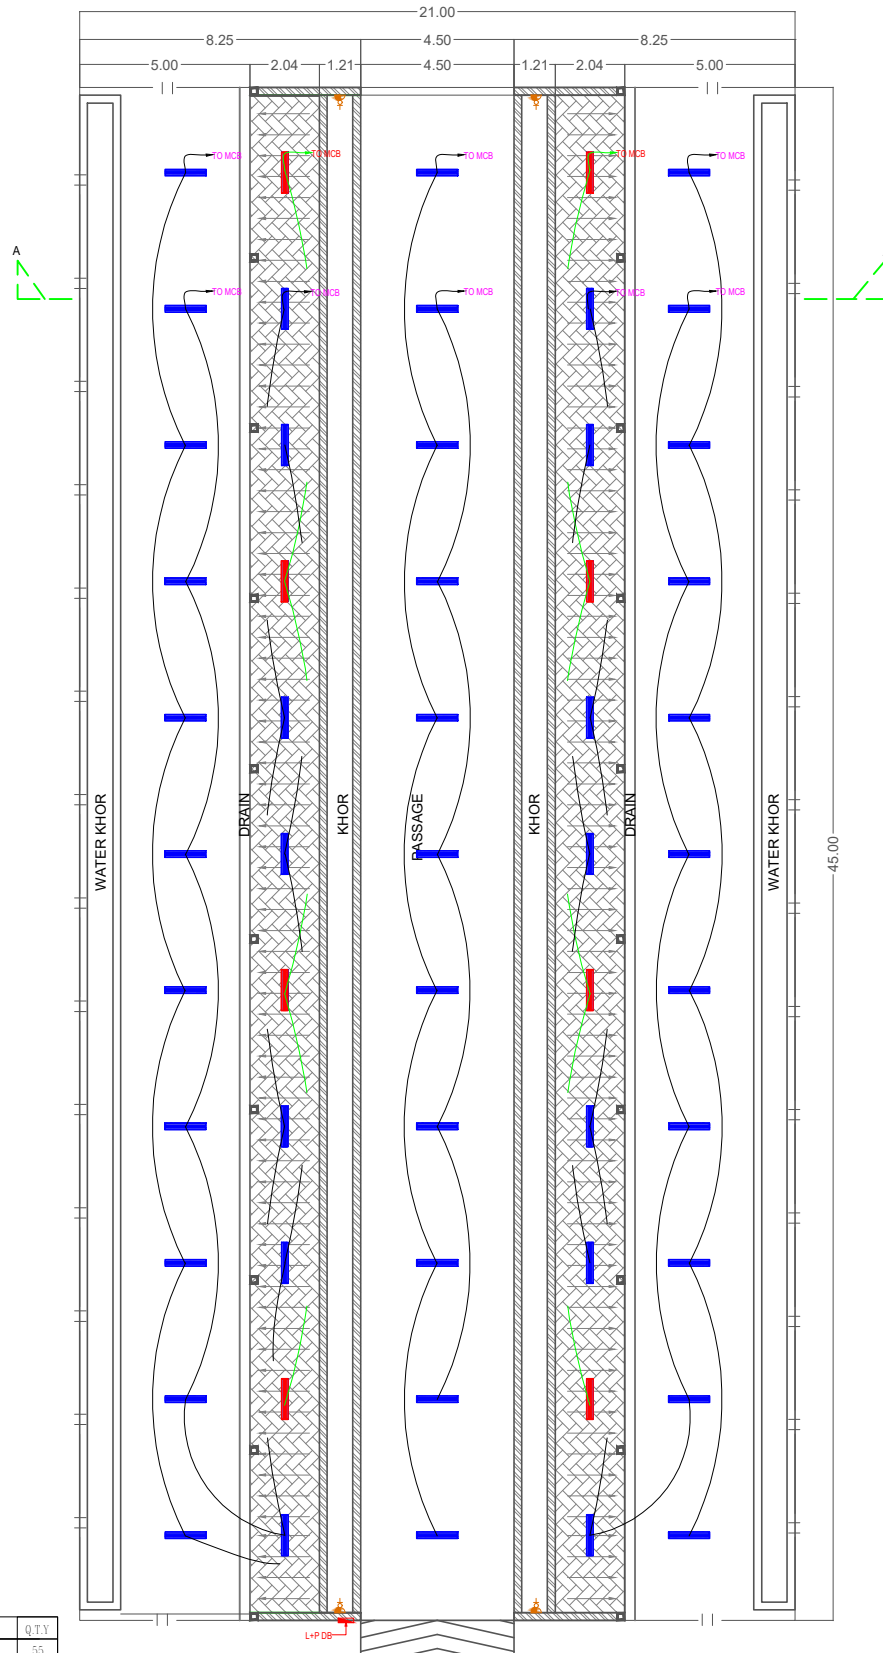

SHELTER PLAN

ELECTRICAL

Sl.No.	SYMBOL	DESCRIPTION	Q.T.Y
1		1x20W LED SURFACE MOUNTED LIGHT	55
2		6/16AMP SOCKET WITH SWITCH	04
3		ONE WAY NORMAL LOOPING.	
4		ONE WAY EMERGENCY	
5		DISTRIBUTION BOARD	01

GENERAL NOTES:
 1. THIS DRAWING AND DESIGN IS THE PROPERTY OF CLA AND NO PARTS MAY BE USED OR REPRODUCED WITHOUT THEIR WRITTEN PERMISSION.
 2. ANY PARTY MUST BE ADVISED OF ANY ADDITIONAL MODIFICATION TO BE MADE TO THE DRAWING BY THE ARCHITECT'S SPECIFIC CONSENT AND IN WRITING.
 3. THIS DRAWING IS TO BE READ IN CONJUNCTION WITH THE SPECIFICATIONS, CONDITIONS AND CONDITIONS OF CONTRACT.
 4. DIMENSIONS NOT SHOWN OR THE LATEST REVISIONS ARE TO BE CIRCLED.
 5. ALL DIMENSIONS AND MATERIALS & GRADES SPECIFIED ARE TO BE EXACTLY AS SHOWN.

CLIENT:
GREATER NOIDA AUTHORITY

DRAWING NO:
GAUSHALA/CLA/APN_EL_01

TENDER DRAWING

PROJECT DATA:
PROPOSED GAUSHALA AT JALPURA, GREATER NOIDA

DRAWING TITLE:
EL - LIGHTING & POWER LAYOUT

ARCHITECT:
CREATIVE ARCHITECTS
 PLOT NO. 15, SECTOR-19, Noida (UTTER PRADESH) 201301
 Mob: +91-9818570796, 9226415476
 Email: creativearchitects@gmail.com

MEP CONSULTANT:
APR
 OFFICE ADD: A-729 BASEMENT, POKHETA SECTOR-19, NOIDA (UTTER PRADESH) 201301
 Cont.No: +91-9818570796
 E-Mail: aprconsultant2@gmail.com
 Web: www.aprconsultant.com

Job No: **01**
 SCALE: **- N.T.S.**

DRAWN BY: **RAJESH**
 CHECKED BY: **ARVIND**

CLIENT MAIL REF:

Sl.No.	Date	By	Description