


SYMBOL	DESCRIPTION	QTY
⚡	6A SWITCH SOCKET OUTLET	15
⚡	16A SWITCH SOCKET OUTLET LIFT	02
⚡	Bulk Head Light	02
⚡	2X6A SWITCH SOCKET OUTLET (UPS)	08
⚡	16A SWITCH SOCKET OUTLET	22
⚡	6AMP 3PIN SOCKET WITH SWITCH FOR TV	02
⚡	16A SWITCH SOCKET OUTLET (UPS)	01
☎	RJ11 TELEPHONE OUTLET	10
📺	TELEVISION OUTLET	02
📡	RJ45 DATA OUTLET	09
📡	PROJECTOR POINT	01
📡	DISTRIBUTION BOARD	01



GROUND FLOOR PLAN

NOTES:- 1. ALL LEVELS ARE GIVEN WITH REGARD TO C.L. OF ROAD AT ENTRANCE GATE 40.00 2. DRAWINGS TO BE READ IN CONJUNCTION WITH RELEVANT CONSULTANTS' DRAWINGS. 3. ANY DISCREPANCIES TO BE BROUGHT TO THE NOTICE OF THE ARCHITECT. 4. DRAWINGS TO BE READ AND NOT SCALED. 5. ALL DIMENSIONS & LEVELS ARE IN M.M.	CLIENT एन टी पी सी लिमिटेड NTPC Limited <small>A GOVERNMENT OF INDIA ENTERPRISE</small> ENGINEERING DIVISION	ARCHITECT: Architects & Acoustics Consultant :- KLM DESIGN (INDIA) ARCHITECTS & ENGINEERS <small>C-79, BASEMENT, MALVIYA NAGAR, NEW DELHI-110017 [P] 011-41931089-99 [E] KLM_DESIGN@YAHOO.CO.IN</small>	<table border="1" style="width: 100%; border-collapse: collapse;"> <thead> <tr> <th>NO.</th> <th>DATE</th> <th>DESCRIPTION</th> </tr> </thead> <tbody> <tr> <td> </td> <td> </td> <td> </td> </tr> <tr> <td> </td> <td> </td> <td> </td> </tr> </tbody> </table>	NO.	DATE	DESCRIPTION							<table border="1" style="width: 100%; border-collapse: collapse;"> <tr> <td>DRAWN</td> <td>RAJESH</td> </tr> <tr> <td>CHECKED BY</td> <td>ARVIND</td> </tr> <tr> <td>STATUS</td> <td>APPROVAL</td> </tr> </table>	DRAWN	RAJESH	CHECKED BY	ARVIND	STATUS	APPROVAL	PROJECT SOLAPUR SUPER THERMAL POWER PROJECT SHEET TITLE ELECTRICAL POWER LAYOUT GROUND FLOOR PLAN	<table border="1" style="width: 100%; border-collapse: collapse;"> <tr> <td>SCALE</td> <td>DATE</td> <td>SHEET SIZE</td> <td>DRAWING NO.</td> </tr> <tr> <td>NTS</td> <td>18.01.22</td> <td>A3</td> <td>EL-01A</td> </tr> </table>	SCALE	DATE	SHEET SIZE	DRAWING NO.	NTS	18.01.22	A3	EL-01A	<table border="1" style="width: 100%; border-collapse: collapse;"> <tr> <td>REVISION NO.</td> <td>R0</td> </tr> </table>	REVISION NO.	R0
NO.	DATE	DESCRIPTION																														
DRAWN	RAJESH																															
CHECKED BY	ARVIND																															
STATUS	APPROVAL																															
SCALE	DATE	SHEET SIZE	DRAWING NO.																													
NTS	18.01.22	A3	EL-01A																													
REVISION NO.	R0																															

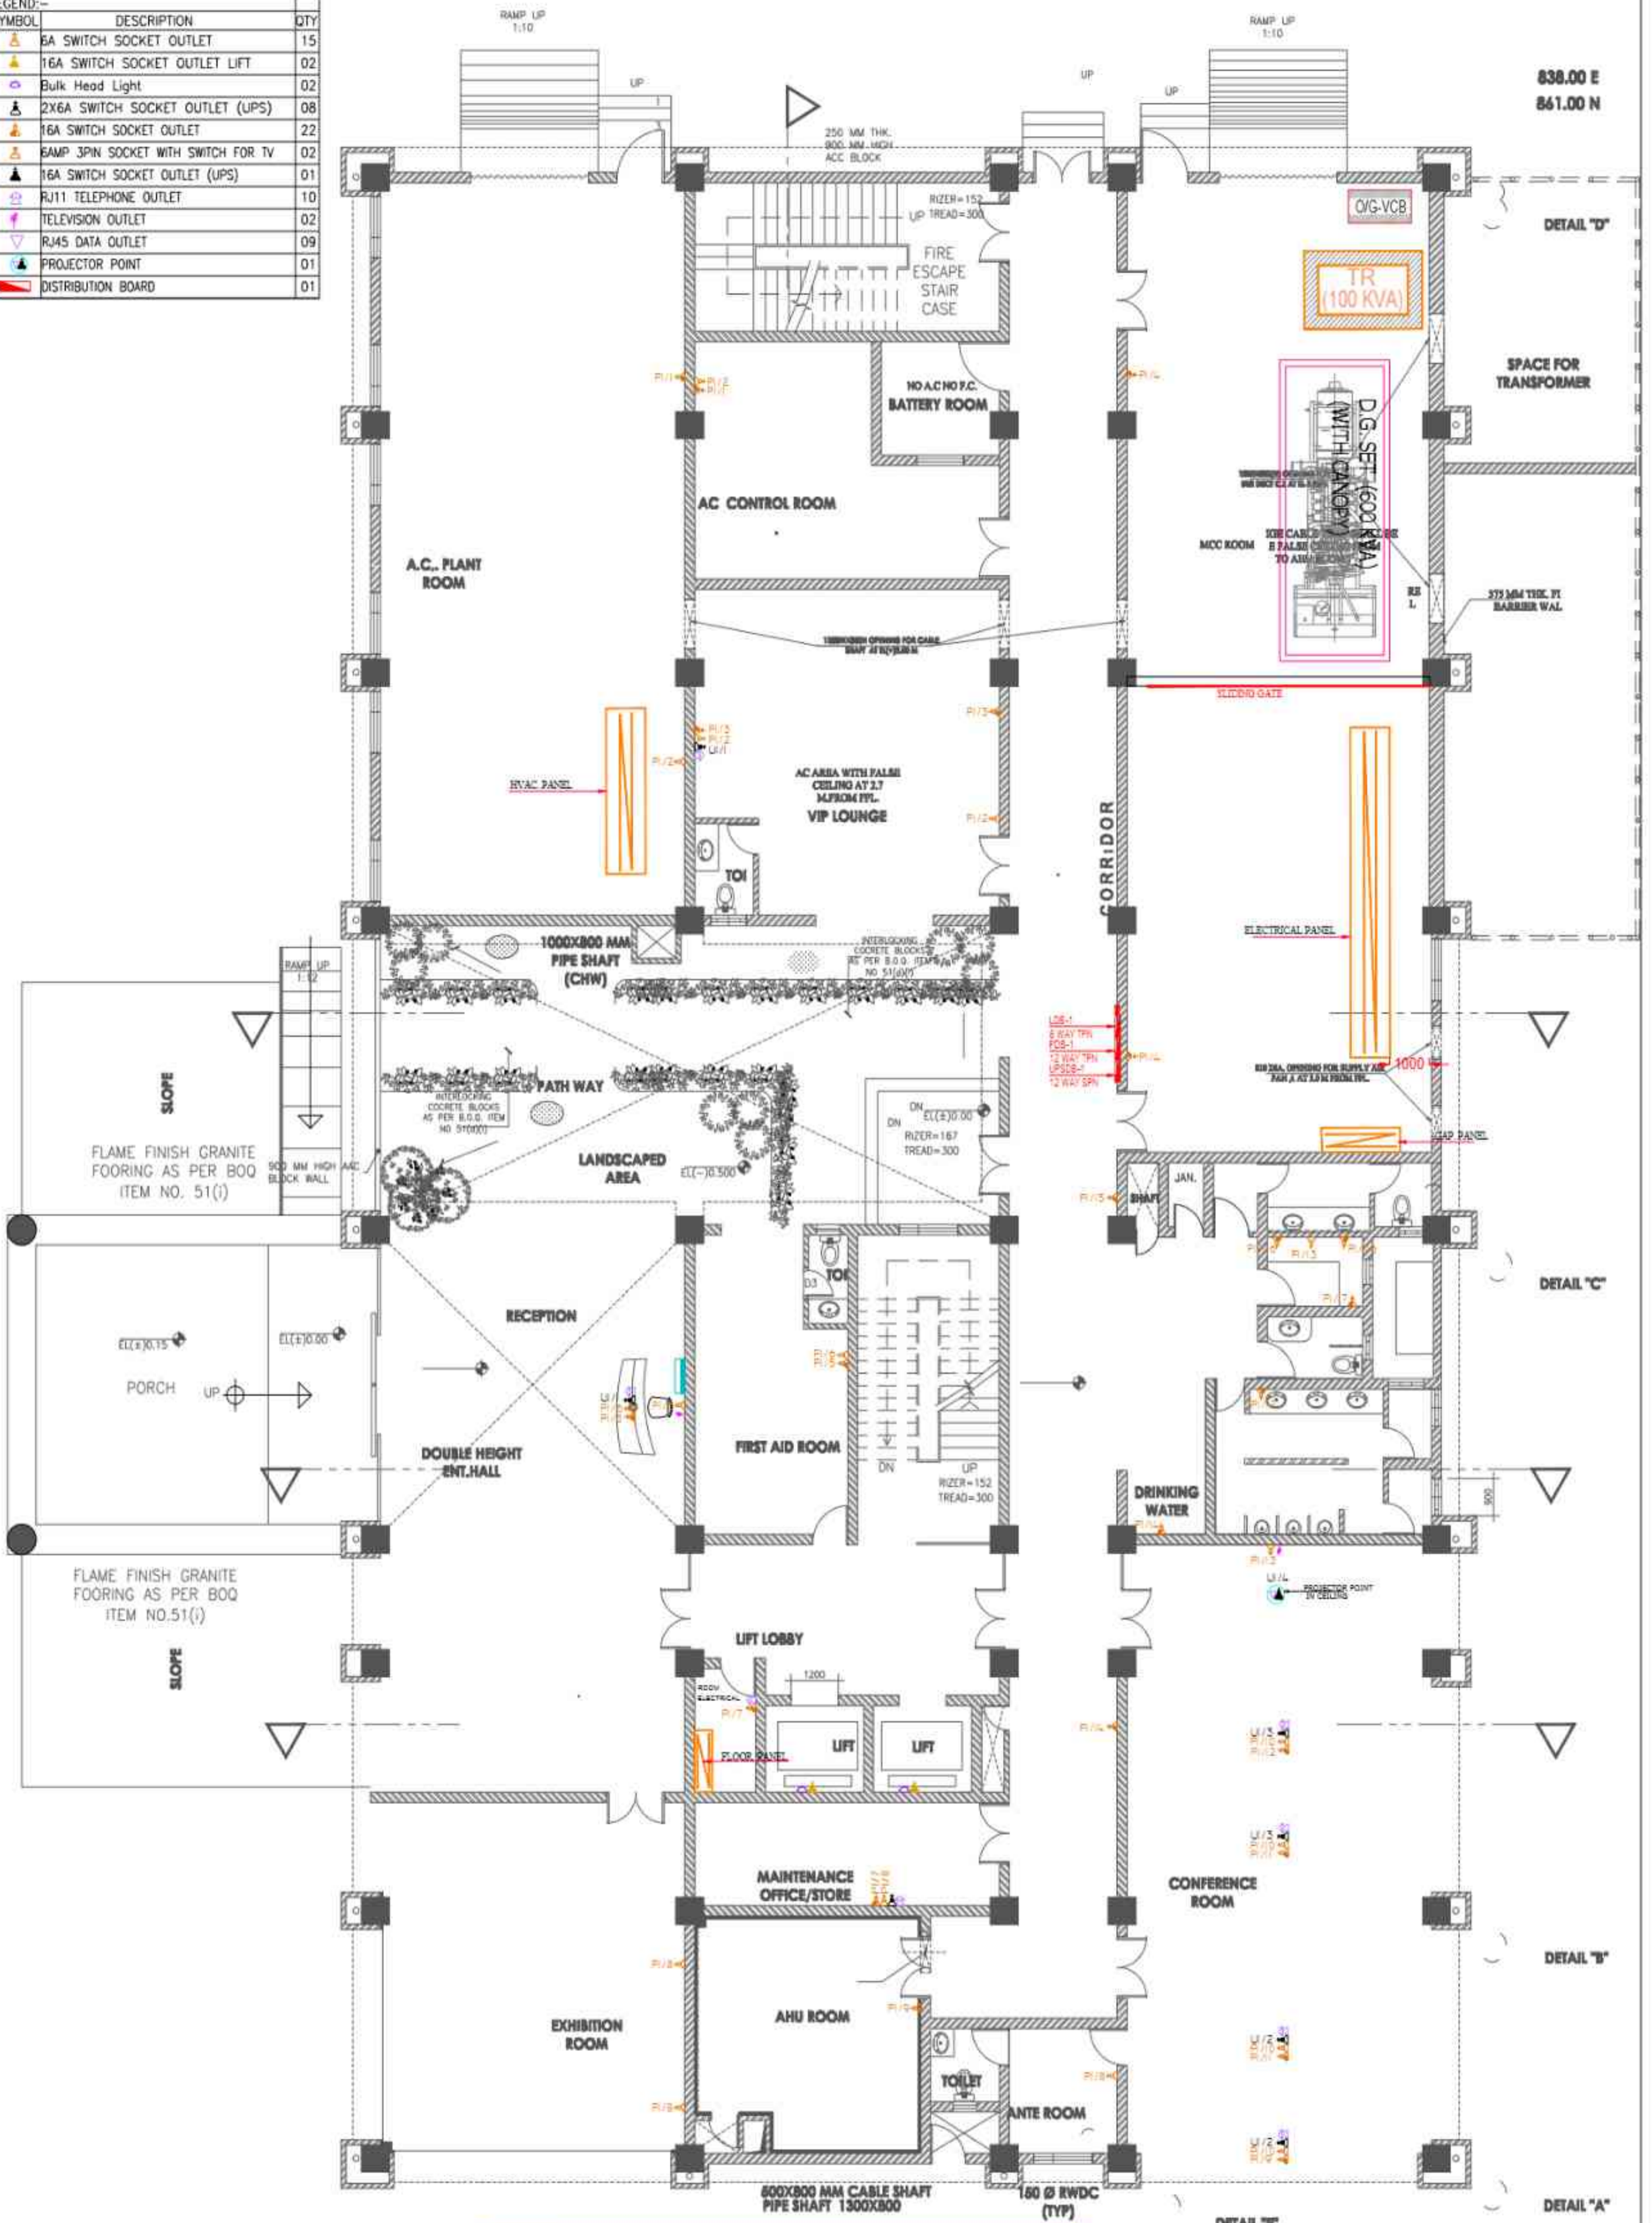