


SYMBOL	DESCRIPTION	QTY
[Symbol]	NORMAL CONTROL SWITCH BOARD	01
[Symbol]	EM CONTROL SWITCH BOARD	01
[Symbol]	20 W LED SURFACE MOUNTED LED	20
[Symbol]	30 W LED LIGHT IN STAIRCASE AREA	08
[Symbol]	30 W LED LIGHT IN CEILING	16
[Symbol]	30 W LED LIGHT CEILING/SURFACE MOUNTED	10
[Symbol]	30 W MIRROR LIGHT	08
[Symbol]	30 W LED LIGHT IN CEILING	09
[Symbol]	30 W LED LIGHT IN CEILING	08
[Symbol]	30 W LED LIGHT IN CEILING	04
[Symbol]	30 W LED TUBE LIGHT IN CEILING	07
[Symbol]	30 W LED LIGHT IN CEILING	06
[Symbol]	30 W LED LIGHT IN CEILING	04
[Symbol]	EMERGENCY LIGHT POINT	07
[Symbol]	EXHAUST FAN	07
[Symbol]	IN SOCKET FOR EX. FAN	07
[Symbol]	DISTRIBUTION BOARD	01

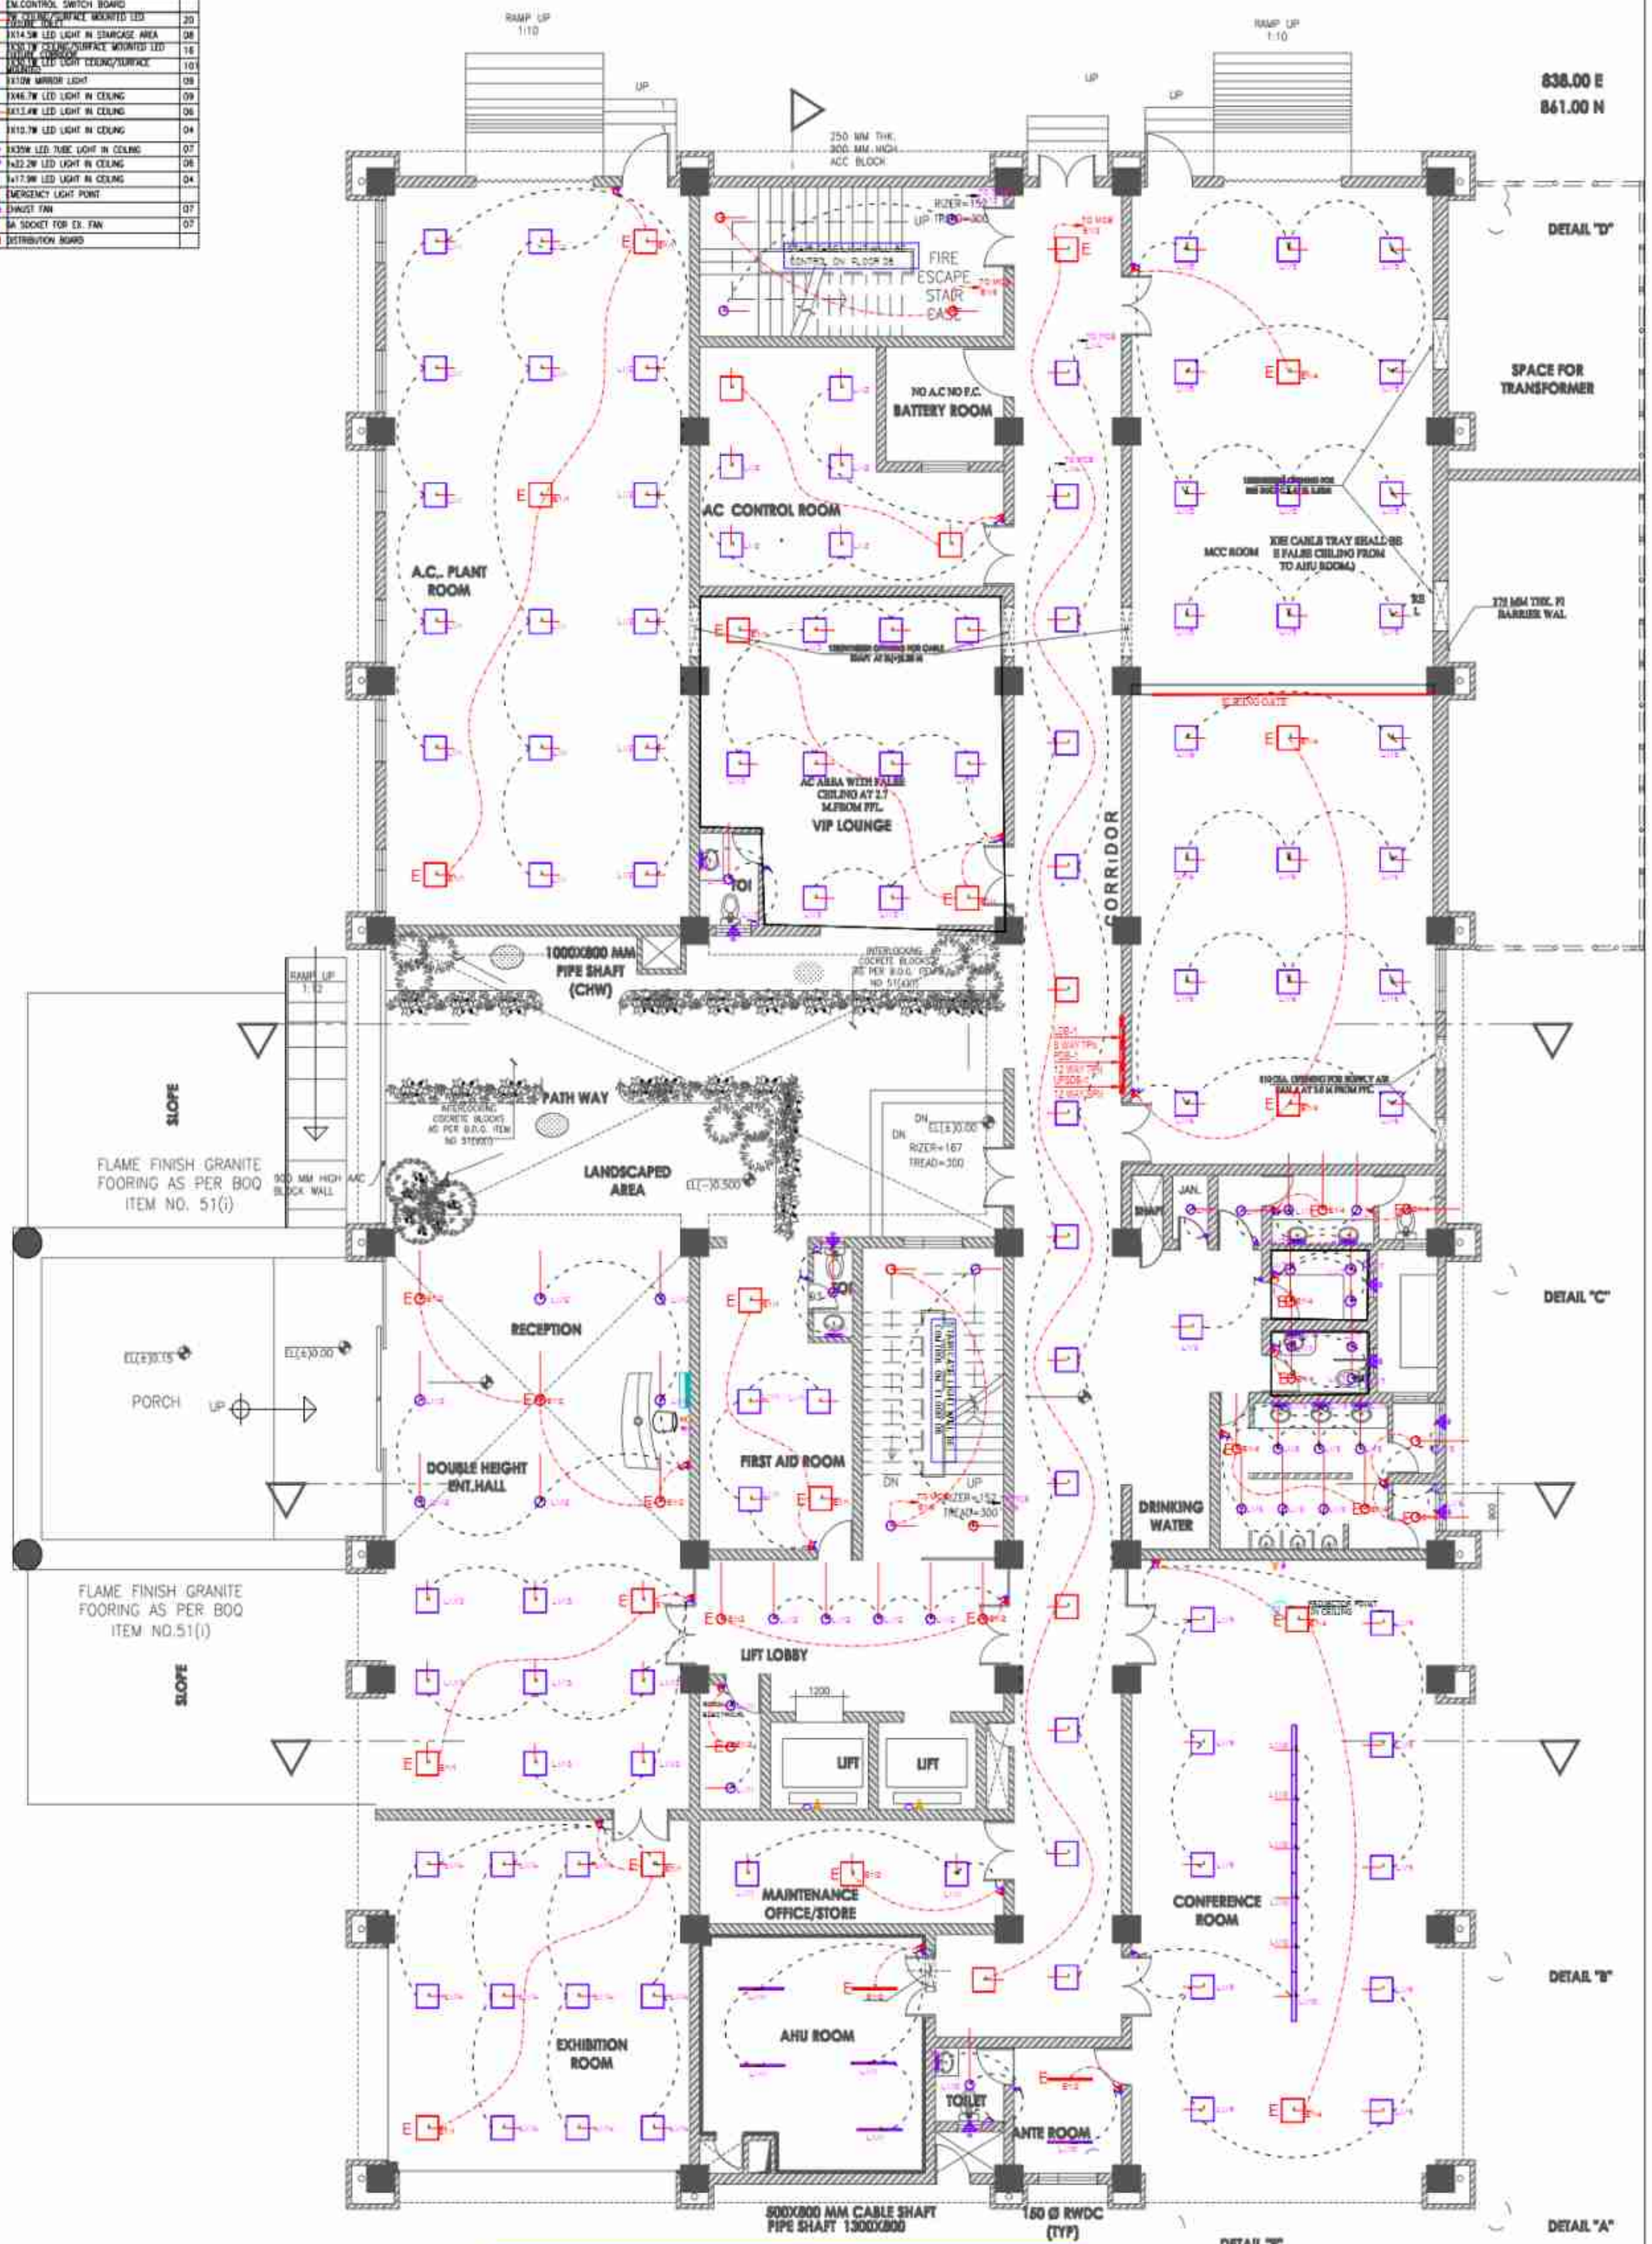

GROUND FLOOR PLAN

NOTES:-

- ALL LEVELS ARE GIVEN WITH RESPECT TO C.L. OF ROAD AT ENTRANCE DATE 42.00
- DRAWINGS TO BE READ IN CONJUNCTION WITH RELEVANT CONSULTANTS' DRAWINGS.
- ANY DISCREPANCIES TO BE BROUGHT TO THE NOTICE OF THE ARCHITECT.
- DRAWINGS TO BE READ AND NOT SCALED.
- ALL DIMENSIONS & LEVELS ARE IN M.M.



ARCHITECTS
Architects & Acoustics Consultant :-
KLM DESIGN (INDIA)
ARCHITECTS & ENGINEERS
C-76 BASEMENT, MALVIYA NAGAR, NEW DELHI-110017
(P) 011-41831089-90 (E) KLM_DESIGN@YAHOO.CO.IN

NO.	DATE	DESCRIPTION	DRAWN	PROJECT
			RAJESH	SOLAPUR SUPER THERMAL POWER PROJECT
			CHECKED BY	SHEET TITLE
			ARVIND	ELECTRICAL LIGHTING LAYOUT
			STATUS	GROUND FLOOR PLAN
			APPROVAL	SCALE
				DATE
				SHEET'S SIZE
				DRAWING NO.
				REVISION NO.

DATE	6.01.22
SCALE	NTS
SHEET'S SIZE	A3
DRAWING NO.	EL-01
REVISION NO.	R0

